

GENERAL NOTES

1. ALL EXIT AND EMERGENCY EGRESS LIGHT FIXTURES SHALL BE CIRCUITED TO NEAREST LIGHTING CIRCUIT VIA UNSWITCHED LEG.
2. ALL EMERGENCY EGRESS LIGHT FIXTURES SHALL BE MOUNTED AT 8'-0" AFF OR 1'-0" BELOW CEILING, WHICH EVER IS LOWEST.
3. PROVIDE WIRE GUARDS FOR ALL FIXTURES IN THE GYMNASIUM, SWIMMING POOL AREA, MECHANICAL, AND ELECTRICAL ROOMS.

NOTES THIS SHEET

- 1 CONTRACTOR TO PROVIDE JUNCTION BOX AND WIRING FOR FUTURE EXIT LIGHT TO BE INSTALLED AT A LATER DATE.
- 2 PROVIDE AND INSTALL LIGHTING CONTROL SWITCHES (4) FOR OVERHEAD GYMNASIUM LIGHTING.
- 3 CONNECT TO EXISTING LIGHTING CIRCUIT AND EXISTING LIGHTING CONTROL.




CONSTRUCTION DOCUMENTS
BID SET



3		
2	BID SET	12/11/02
1	PERMIT CORRECTIONS	7/15/02
NO.	REVISION - AS BUILT	DATE

REVIEWED: *[Signature]* 1/15/03
PARK ENGINEER DATE

All work done in accordance with the City of Seattle Standard Plans and Specifications in effect on the date shown above, and supplemented by Special Provisions.

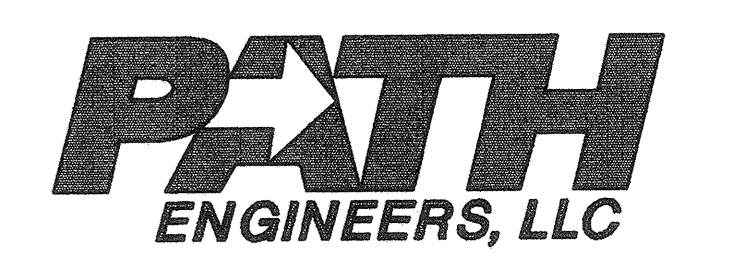

17928 BOTHELL EVERETT HWY SE, SUITE H
BOTHELL, WASHINGTON 98012
(425) 481-7735 FAX (425) 481-7692

CONTACT: FRANK STARR
JOB NUMBER: 023261

SAND POINT
MAGNUSON PARK
COMMUNITY RECREATION CENTER
BUILDING 47

GROUND FLOOR LIGHTING PLAN	
XXX	
DESIGNED: FHS	DATE: JULY 23, 2002
DRAWN: MDW	DESIGN REVIEW:
CHECKED: LDB	
ORDINANCE NO. 119812 & 119987	SHEET 68 OF 76
CONTRACT NO. 1616	
SCALE: 1/8" = 1'-0"	

GROUND FLOOR LIGHTING PLAN
SCALE: 1/8" = 1'-0"
NORTH